

**EVOLVE**

**EPTC Twin Support Contemporary**

LED Post Top Light

*Catalog Logic & Spec Tables*

Project Name \_\_\_\_\_

Date \_\_\_\_\_ Type \_\_\_\_\_



Notes \_\_\_\_\_

Not all product variations listed on this page are DLC qualified.  
Visit [www.designlights.org/search](http://www.designlights.org/search) to confirm qualification.

Page 2 of 4  
(Rev 12/19/23)  
OLP2091\_R01

JOB NO.  
24-83



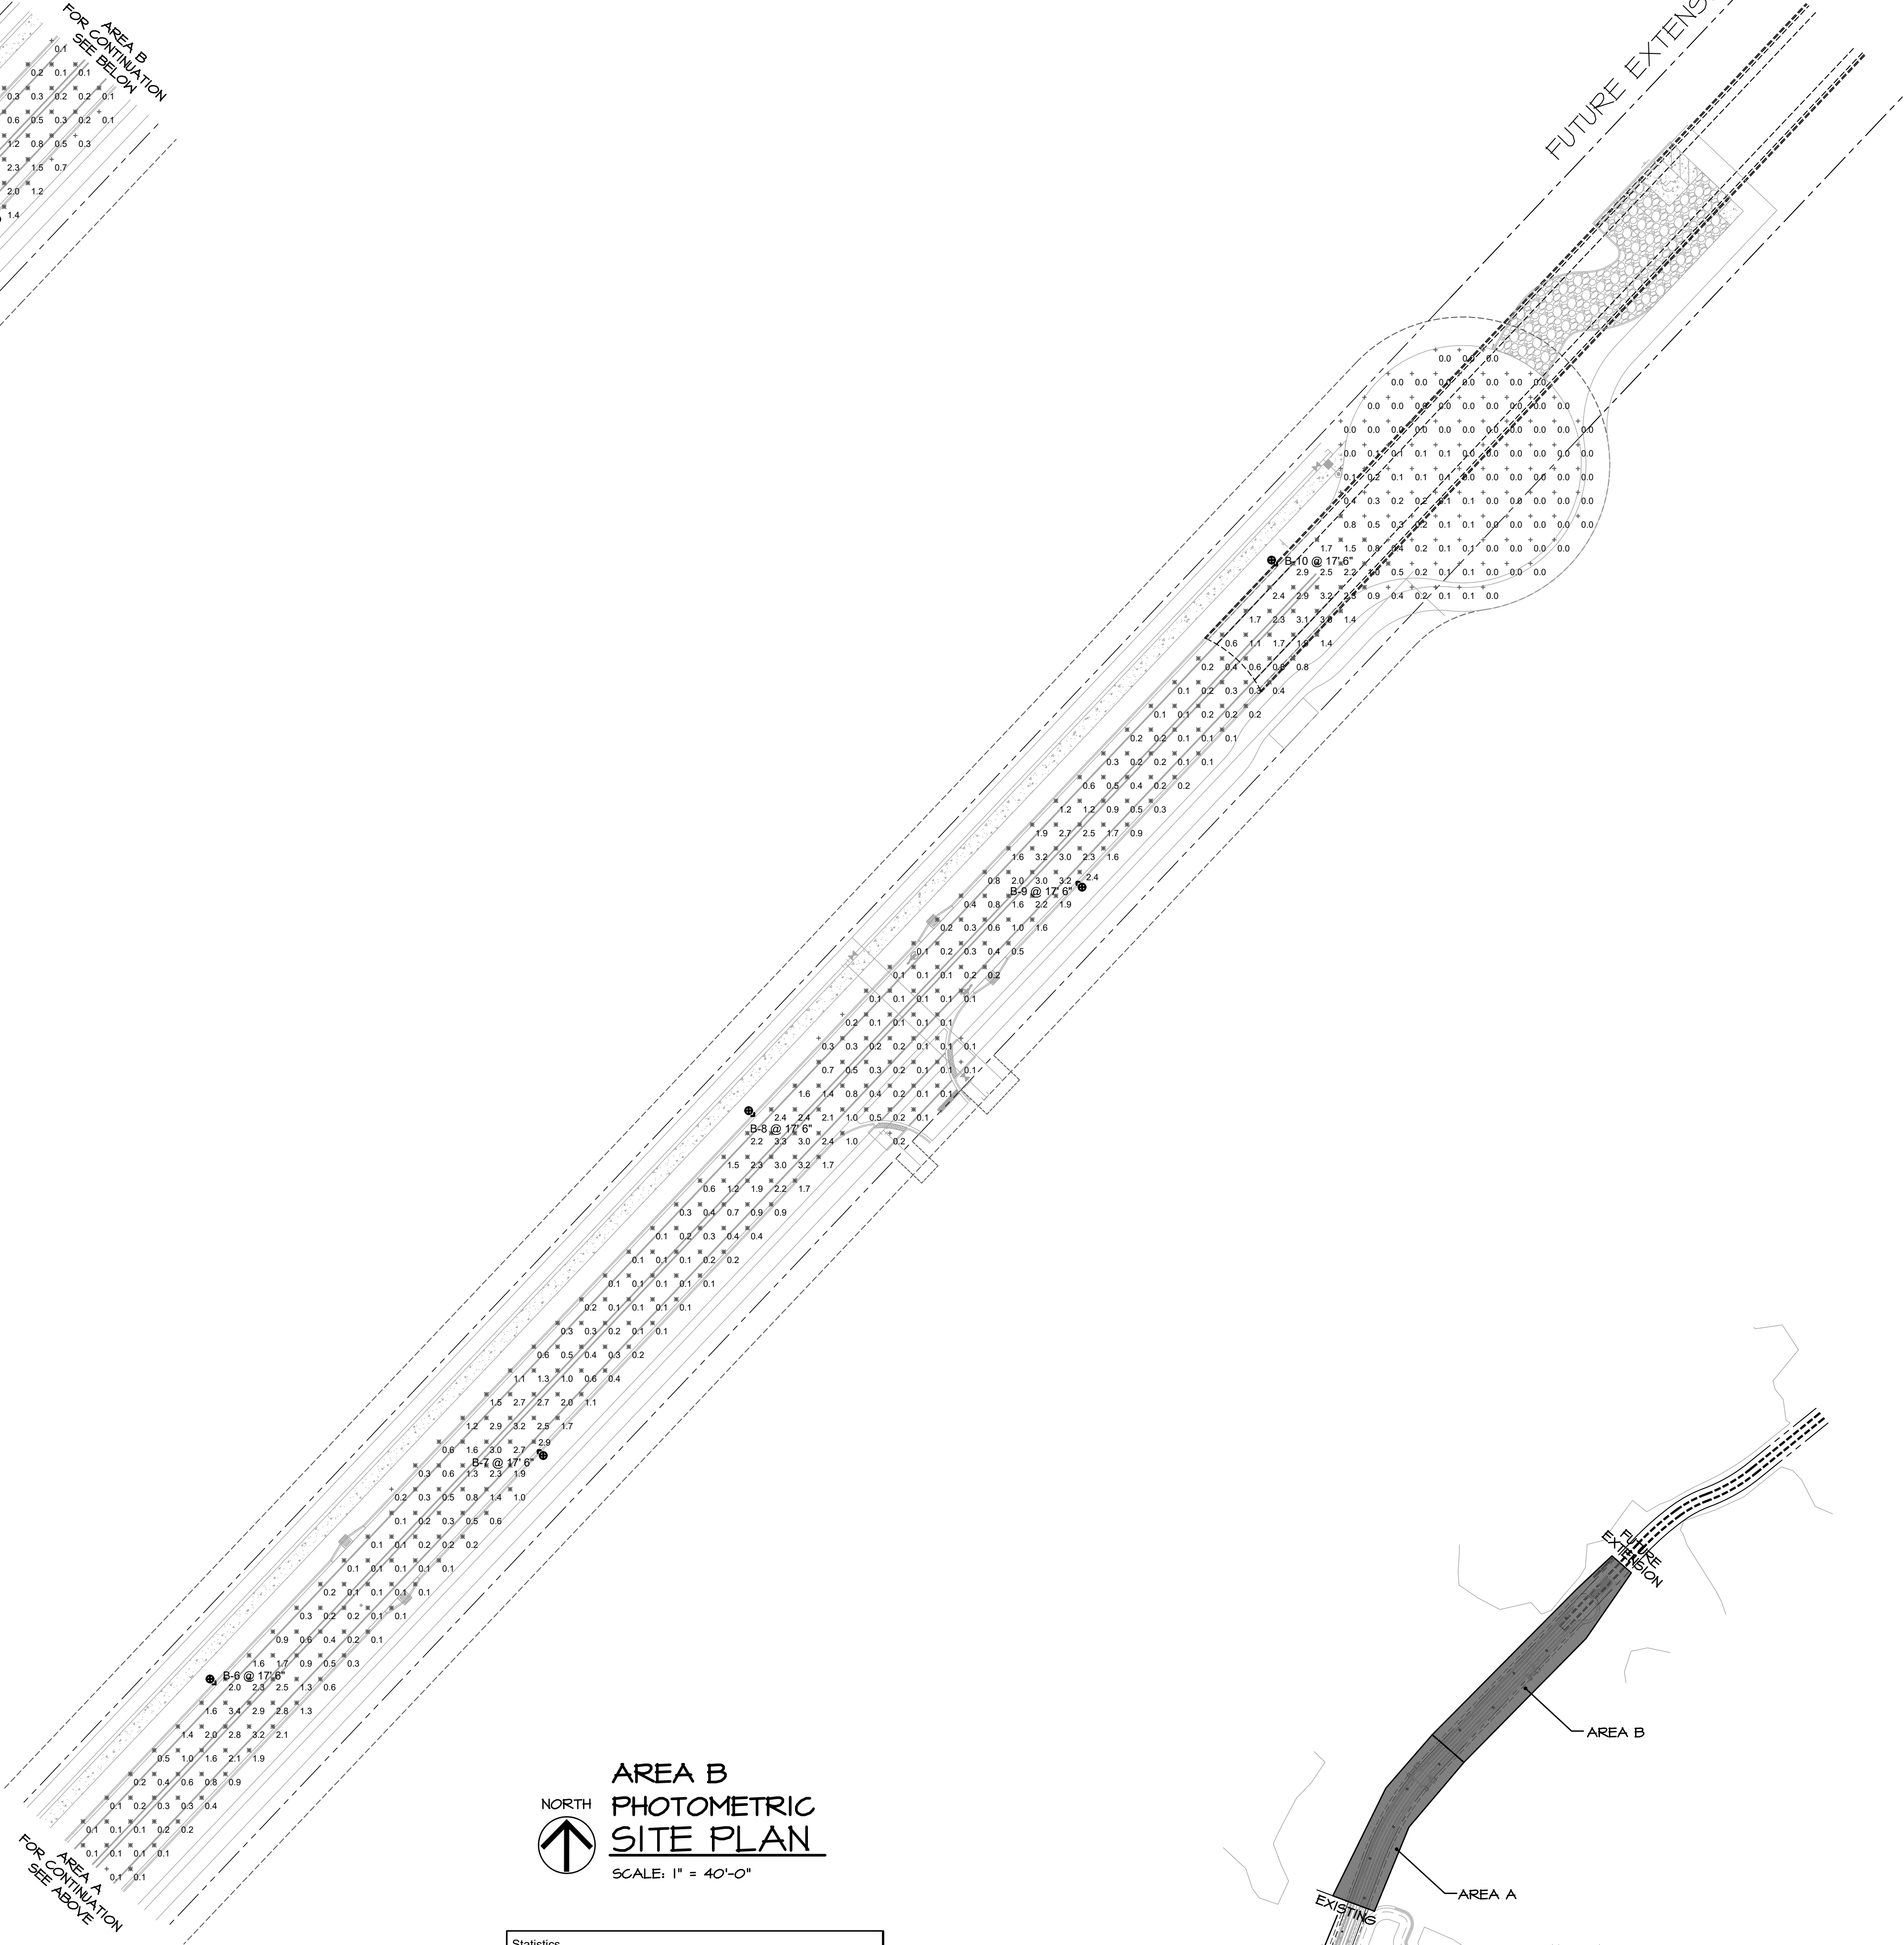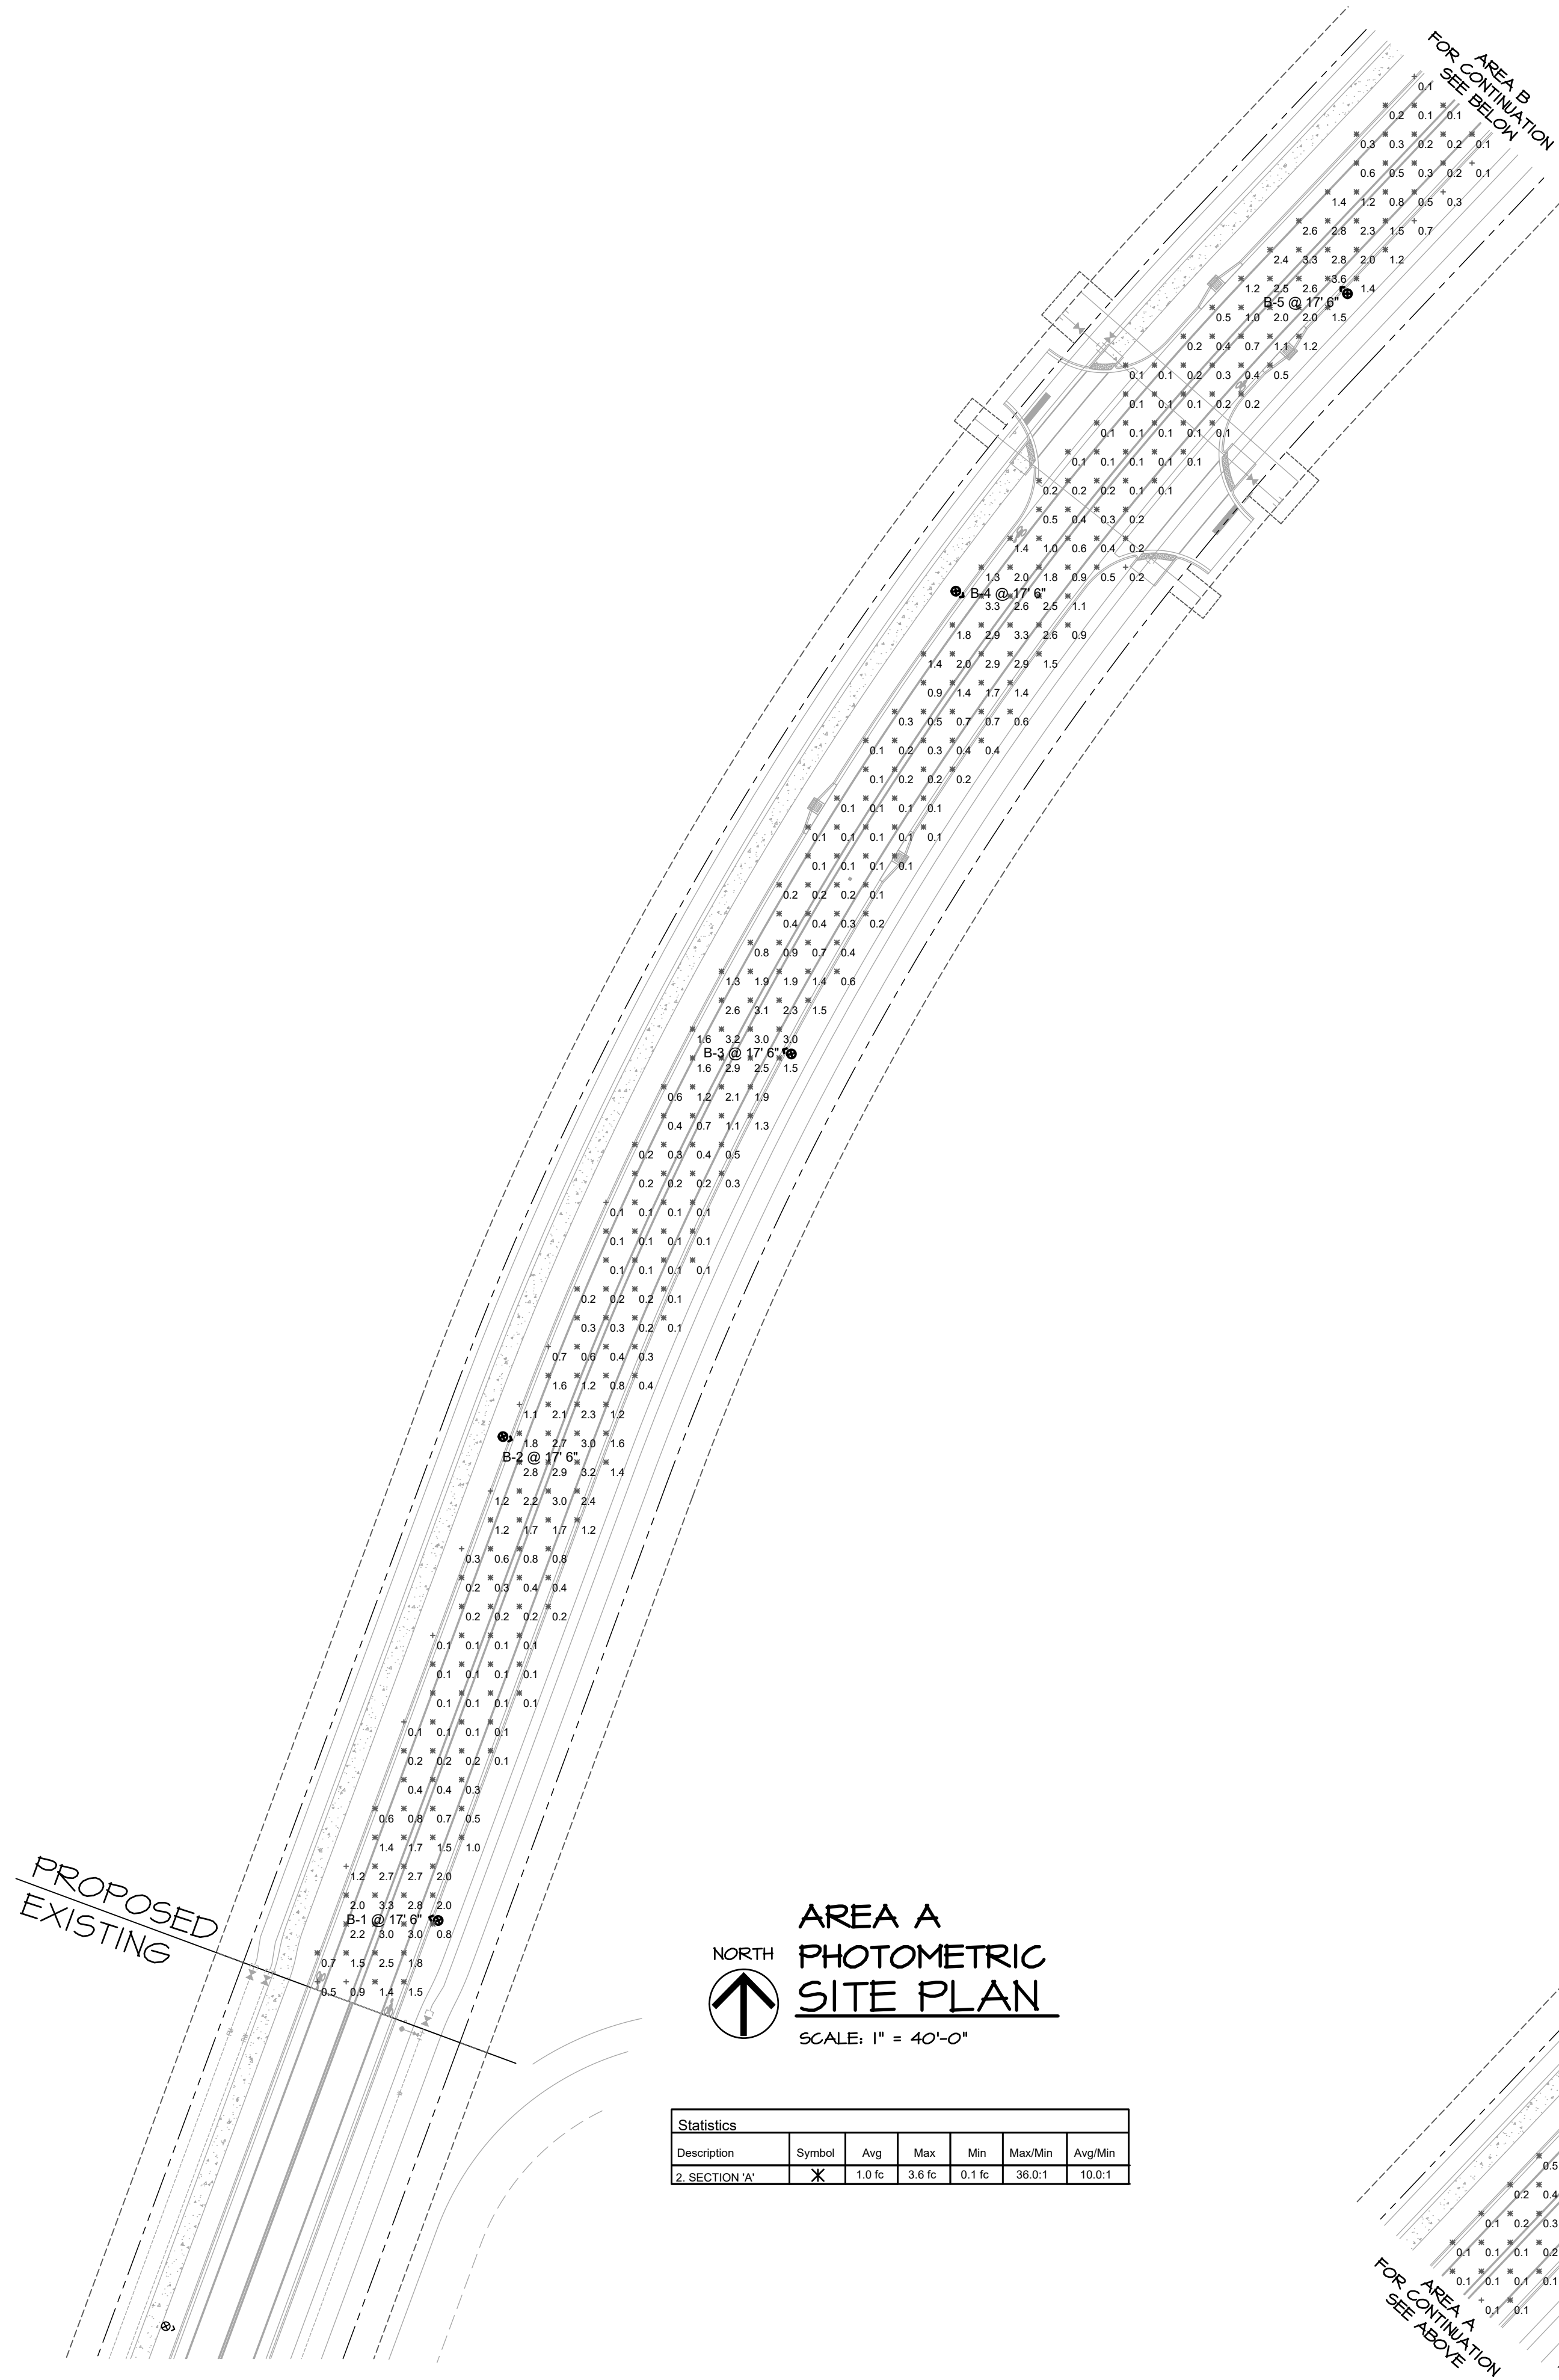

DATE	08-24-24	DRAWN BY	DATE	08-24-24	CHECKED BY	SCALE
NO.			NO.			
REVISION			REVISION			

PROJECT LOCATION	Wildlight Avenue Lighting Plan
Phase	Phase 4
Yulee, FL 32097	
SHEET TITLE	PHOTOMETRIC SITE PLAN

PROJECT LOCATION	
Wildlight Avenue Lighting Plan	
Phase 4	
Yulee, FL 32097	
SHEET TITLE	PHOTOMETRIC SITE PLAN

SHEET NO.	E2
JOB NO.	24-03